

PROJECT NAME / LOCATION:
PROPOSED NEW BUILDING
GED S MAIN DIST., LLC
 PODS STORAGE FACILITY
 South Main Street
 Bridgeville, DE 19933
 Town of Bridgeville
 Sussex County Delaware


ARCHITECT:

 ARCHITECTURAL COLLABORATIVE, PLLC
 687 OLD WILLETS PATH
 HAUPPAUGE • NEW YORK • 11788
 631.793.9684
 rkent.tkac@gmail.com

CONSTRUCTION MANAGER / GENERAL CONTRACTOR:

 CONSTRUCTION MANAGEMENT & GENERAL CONTRACTING
 687 OLD WILLETS PATH
 HAUPPAUGE, NEW YORK 11788
 TEL: 631-435-1818
 FAX: 631-273-7673

STRUCTURAL ENGINEER:
NUCOR BUILDING SYSTEMS
 P.O. Box 1006
 200 Whetstone Road
 Swansea, SC 29160
 Tel: 803.568.2100
 Fax: 803.568.2121

STRUCTURAL ENGINEER:

 Engineering, Design, Construction Services
 326 WARD ST. SCRANTON, PA 18512-2424
 PHONE (570) 496-7020 FAX (570) 496-7021

| | |
|--------------------------------------|------------|
| PRELIMINARY SITE - P6 + LINE OF SITE | 2022.06.03 |
| ISSUED FOR SKETCH PLAN REVIEW | 2021.08.30 |
| EXHIBIT PLAN | 2021.08.24 |
| PRELIMINARY SITE - P4 | 2021.06.21 |
| PRELIMINARY SITE - P3 | 2021.06.21 |
| PRELIMINARY SITE - P2 | 2021.06.18 |
| PRELIMINARY SITE - P1 | 2021.06.01 |
| REVISION: | DATE: |

SEAL:


DRAWING TITLE:
CONCEPT BUILDING / SITE PLAN

DATE:
 2021.06.01

DRAWN BY:
 RK/BMF

PROJECT NO.:
 21.38

DRAWING NO.:
SP.2

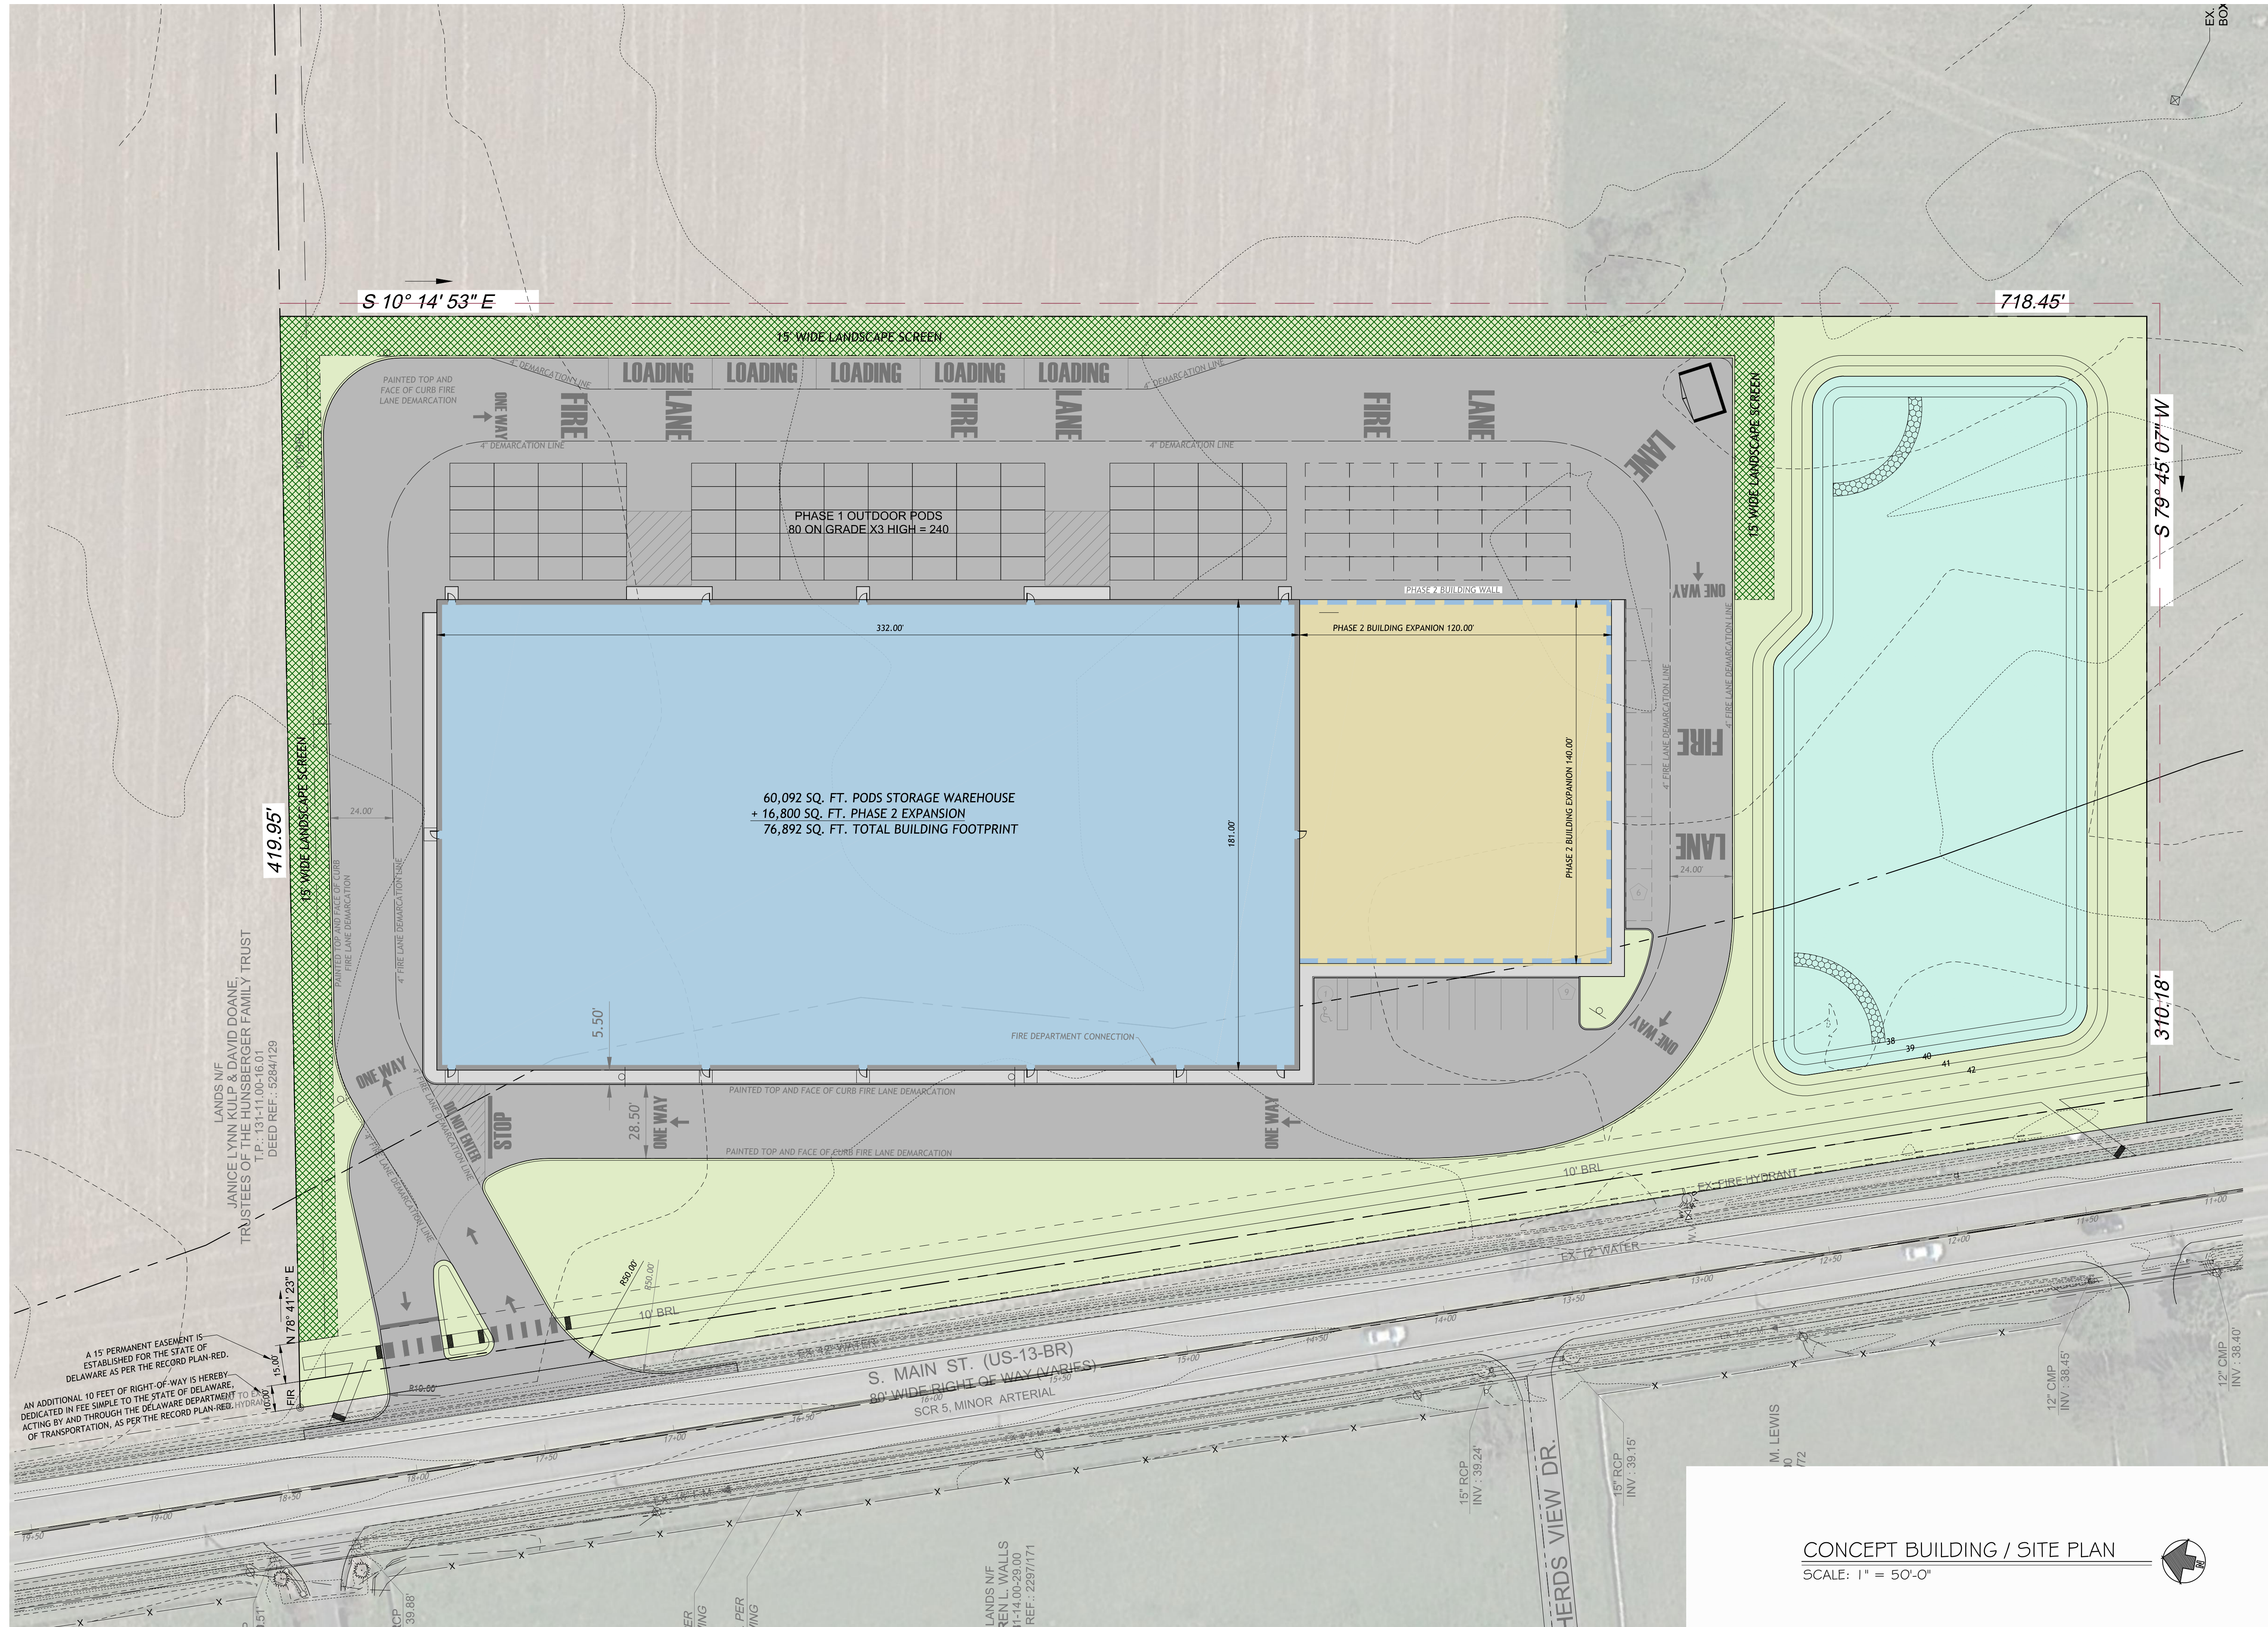

CONCEPT BUILDING / SITE PLAN
 SCALE: 1" = 50'-0"