


PROJECT NAME / LOCATION:  
**PROPOSED NEW BUILDING**  
**GED S MAIN DIST., LLC**  
 PODS STORAGE FACILITY  
 SOUTH MAIN STREET  
 BRIDGEVILLE, DE 19933  
 TOWN OF BRIDGEVILLE  
 SUSSEX COUNTY DELAWARE

ARCHITECT:  
  
 ARCHITECTURAL COLLABORATIVE, PLLC  
 687 OLD WILLETS PATH  
 HAUPPAUGE • NEW YORK • 11788  
 631.793.9684  
 rkent.kac@gmail.com


CONSTRUCTION MANAGER / GENERAL CONTRACTOR:  
  
 687 OLD WILLETS PATH  
 HAUPPAUGE • NEW YORK • 11788  
 TEL: 631.435.1818  
 FAX: 631.273.7673

STRUCTURAL ENGINEER:  
**NUCOR BUILDING SYSTEMS**  
 P.O. Box 1006  
 200 Whetstone Road  
 Swansea, SC 29160  
 Tel: 803.568.2100  
 Fax: 803.568.2121

STRUCTURAL ENGINEER:  
  
 Engineering, Design, Construction Services  
 326 WARD ST. SCRANTON, PA 18512-2424  
 PHONE (570) 496-7020 FAX (570) 496-7021


MECH / ELEC / PLUMBING ENGINEER:  
  
 2007 HIGHWAY 315, SUITE 202 PITTSBURGH, PA 15222  
 PHONE (724) 299-7520

OWNER MARKUPS 2022.10.07  
 ISSUED FOR PERMIT 2021.02.18  
 REVISED LOWERED BUILDING HEIGHT AND REMOVED ROOF SKYLIGHTS 2021.02.11  
 ISSUED FOR REVIEW AND COORDINATION 2021.11.11  
 EXHIBIT PLAN 2021.08.30  
 PRELIMINARY SITE - P4 2021.08.24  
 PRELIMINARY SITE - P3 2021.06.21  
 PRELIMINARY SITE - P2 2021.06.18  
 PRELIMINARY SITE - P1 2021.06.18

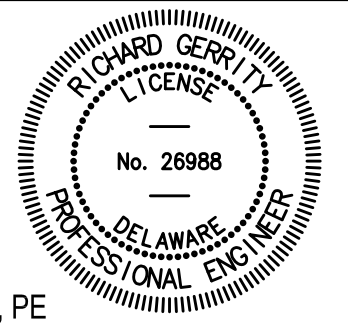REVISION: DATE:  
 SEAL:  
  
 RICHARD GERRITY, PE  
 LICENSE No. 26988

DRAWING TITLE:  
**SITE PHOTOMETRIC PLAN**

DATE: 2021.06.01 DRAWING NO.:  
 DRAWN BY: BSR/G **E1.1**  
 PROJECT NO.: 21.38

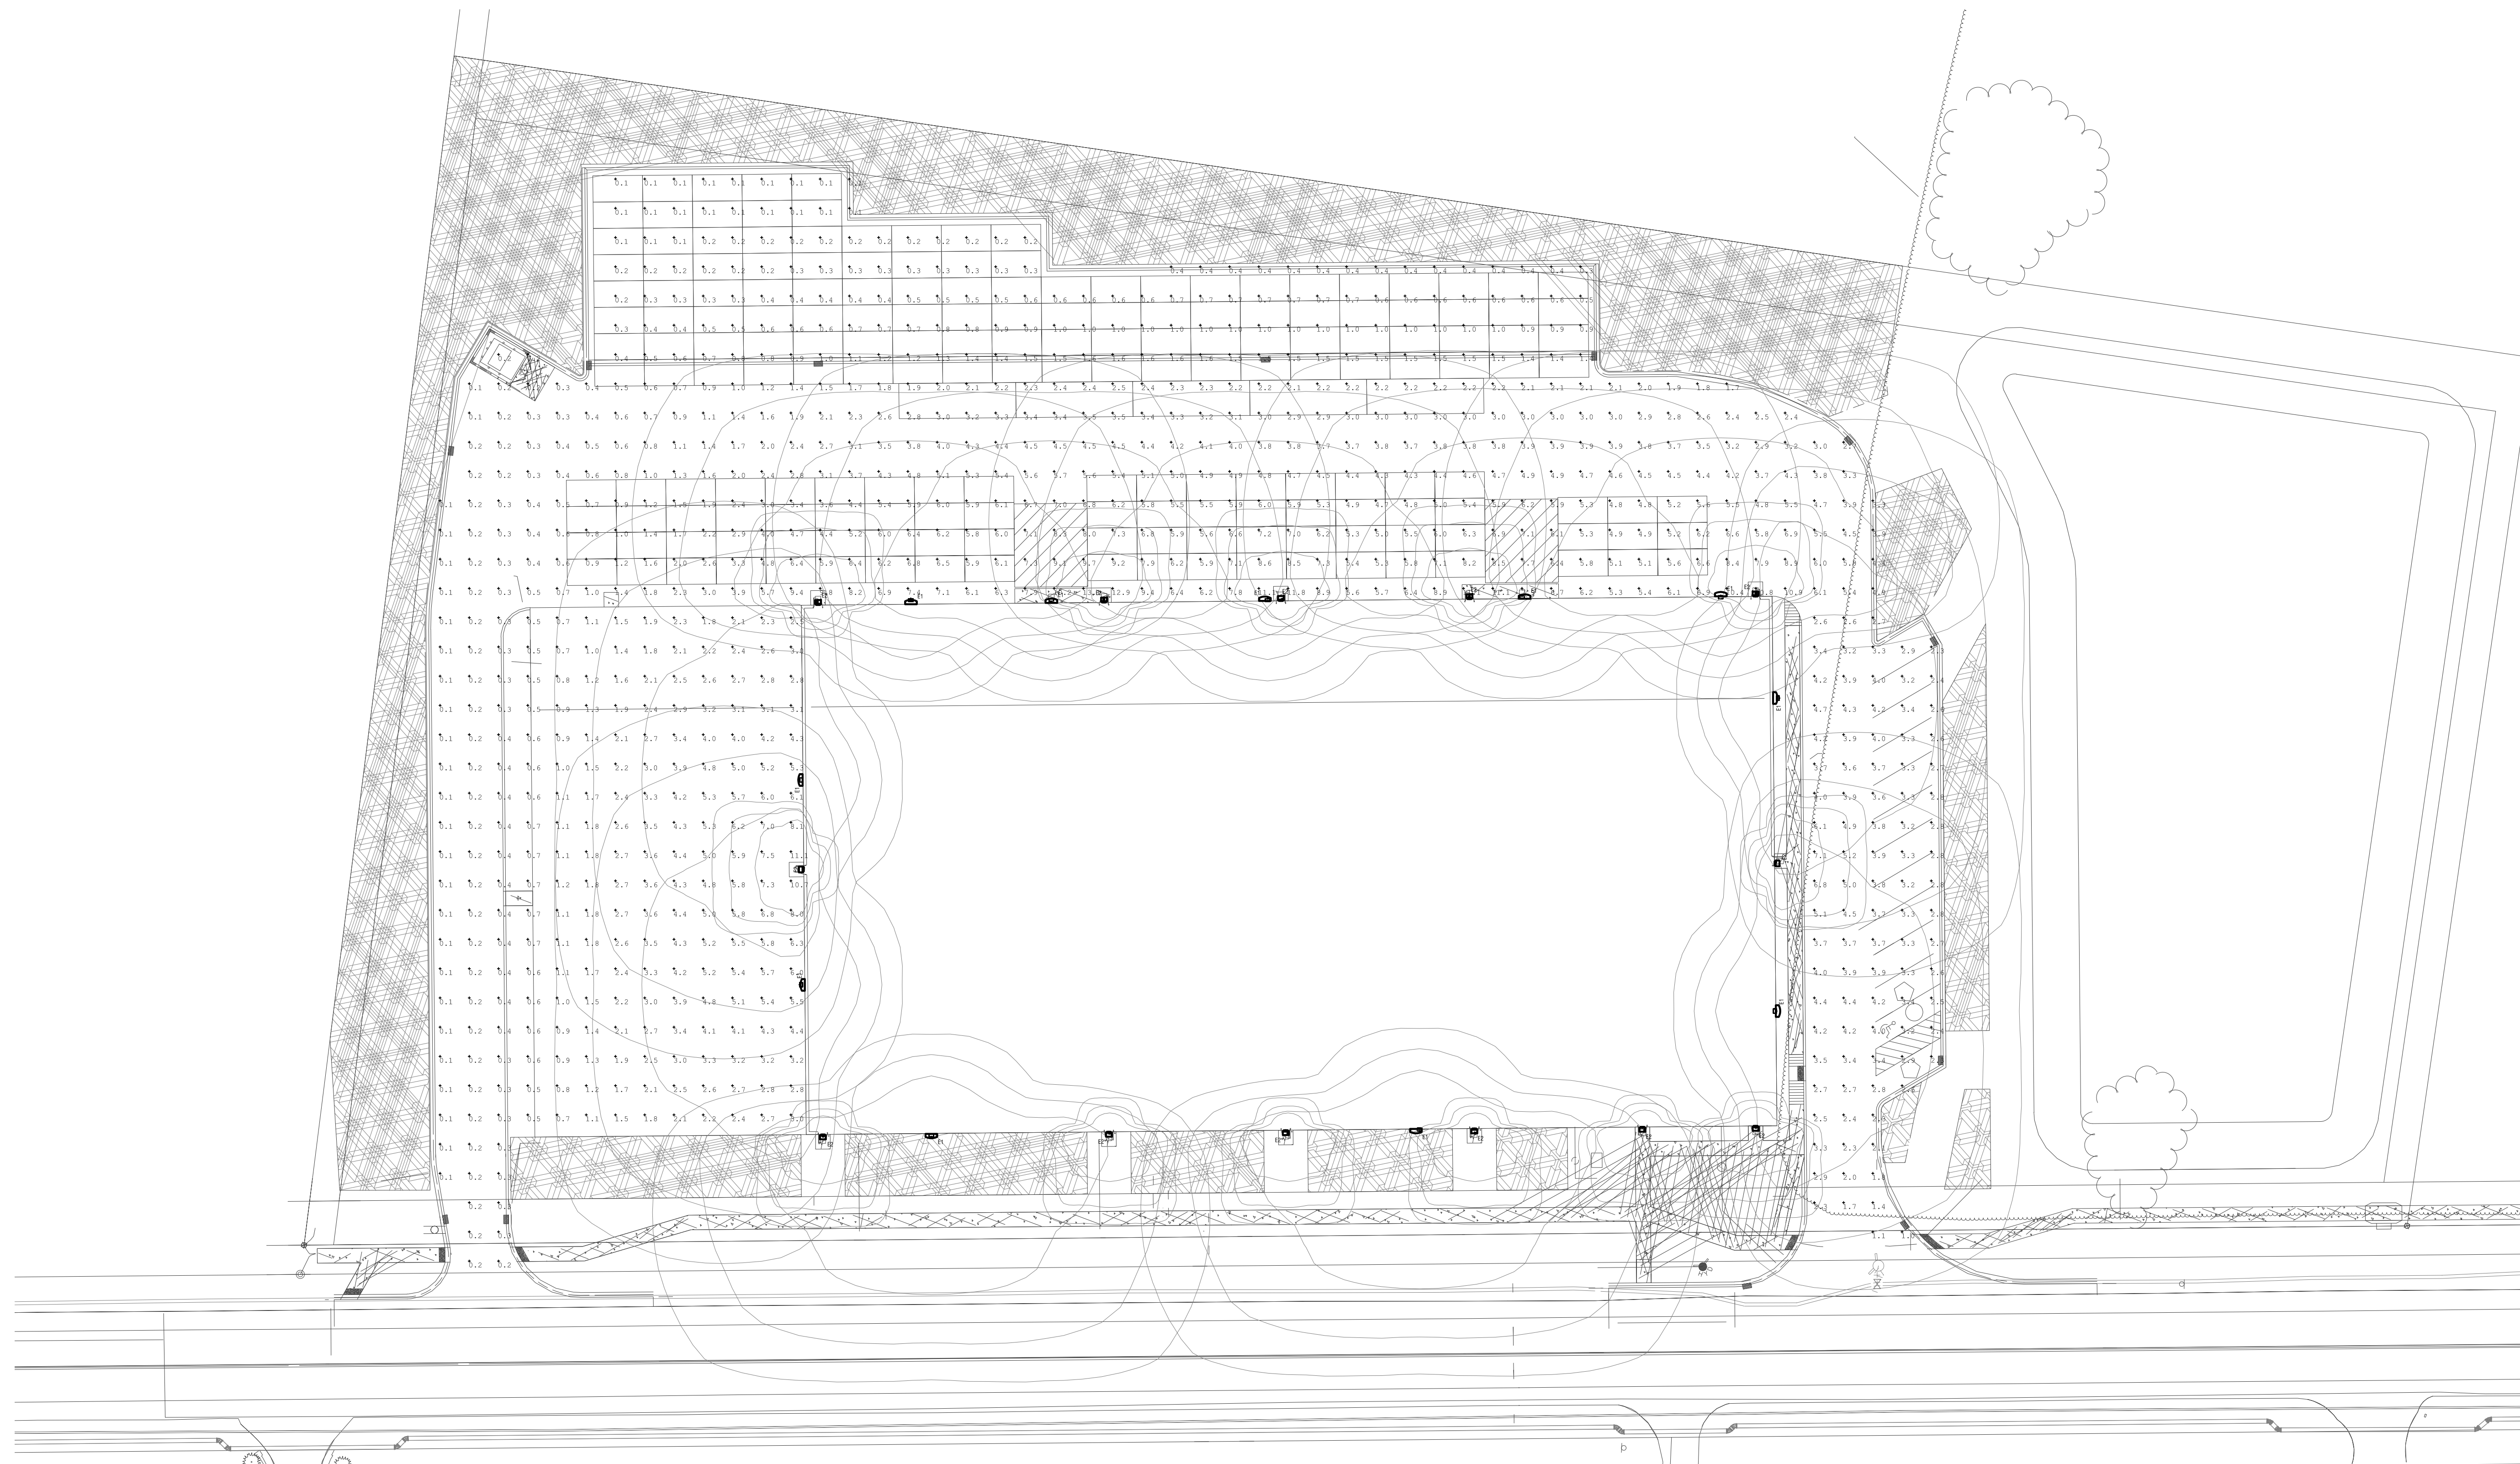

**1 SITE LIGHTING PLAN**  
 E1.1 SCALE: 1" = 20'-0"

SITE LIGHTING FIXTURE SCHEDULE							
TYPE	CATALOG No.	DESCRIPTION	LAMP	VOLTS	MNT HT	B-U-G	REMARKS
C1	MCGRAW-EDISON Cat No. GLENON-AF-06-LED-277-14W-BZ-WM-F	EXTERIOR WALL MOUNTED LED FIXTURE	382W LED	UNV	32'-4"	B4-U0-G5	
LB	MCGRAW-EDISON Cat No. IST-AF-600-LED-277-14FT-BZ-MS-DIM-LXX	EXTERIOR WALL MOUNTED LED FIXTURE	34W LED	UNV	8'-9"	B1-U0-G1	PROVIDE EMERG BATTERY BACKUP
<b>NOTES:</b>							
1. ALL SITE LIGHTING FIXTURES SHALL HAVE 0 UPLIGHT PER IES TM-15-07.							
2. COORDINATE FINAL FIXTURE SELECTIONS, COLOR TEMPERATURE, AND FINISHES WITH ARCHITECT AND OWNER. POLES AND FIXTURES ARE TO MATCH EXISTING NEIGHBORING LOT.							
3. PROVIDE ALL REQUIRED MOUNTING HARDWARE, COMPONENTS, ACCESSORIES, POLE BASES, PHOTOCELLS, ETC. AS REQUIRED FOR A COMPLETE INSTALLATION.							
	AVERAGE	MAX	MIN	MAX:MIN	AVG:MIN	LLF	
LOT	2.86	13.1	0.10	131.00	28.60	0.9	